


LEGEND	
NH-1	WATER HEATER
HM	HOT WATER
CM	COLD WATER
SS	SANITARY SEWER
V	VENT
6	GAS
6	GAS REGULATOR VALVE
6	GAS METER
6	MATER METER
6	CLEAN OUT
6	WALL CLEAN OUT
6	VENT THRU ROOF
6	TRAP SEAL PRIMER
6	BACKFLOW PREVENTER
6	SHUT OFF VALVE

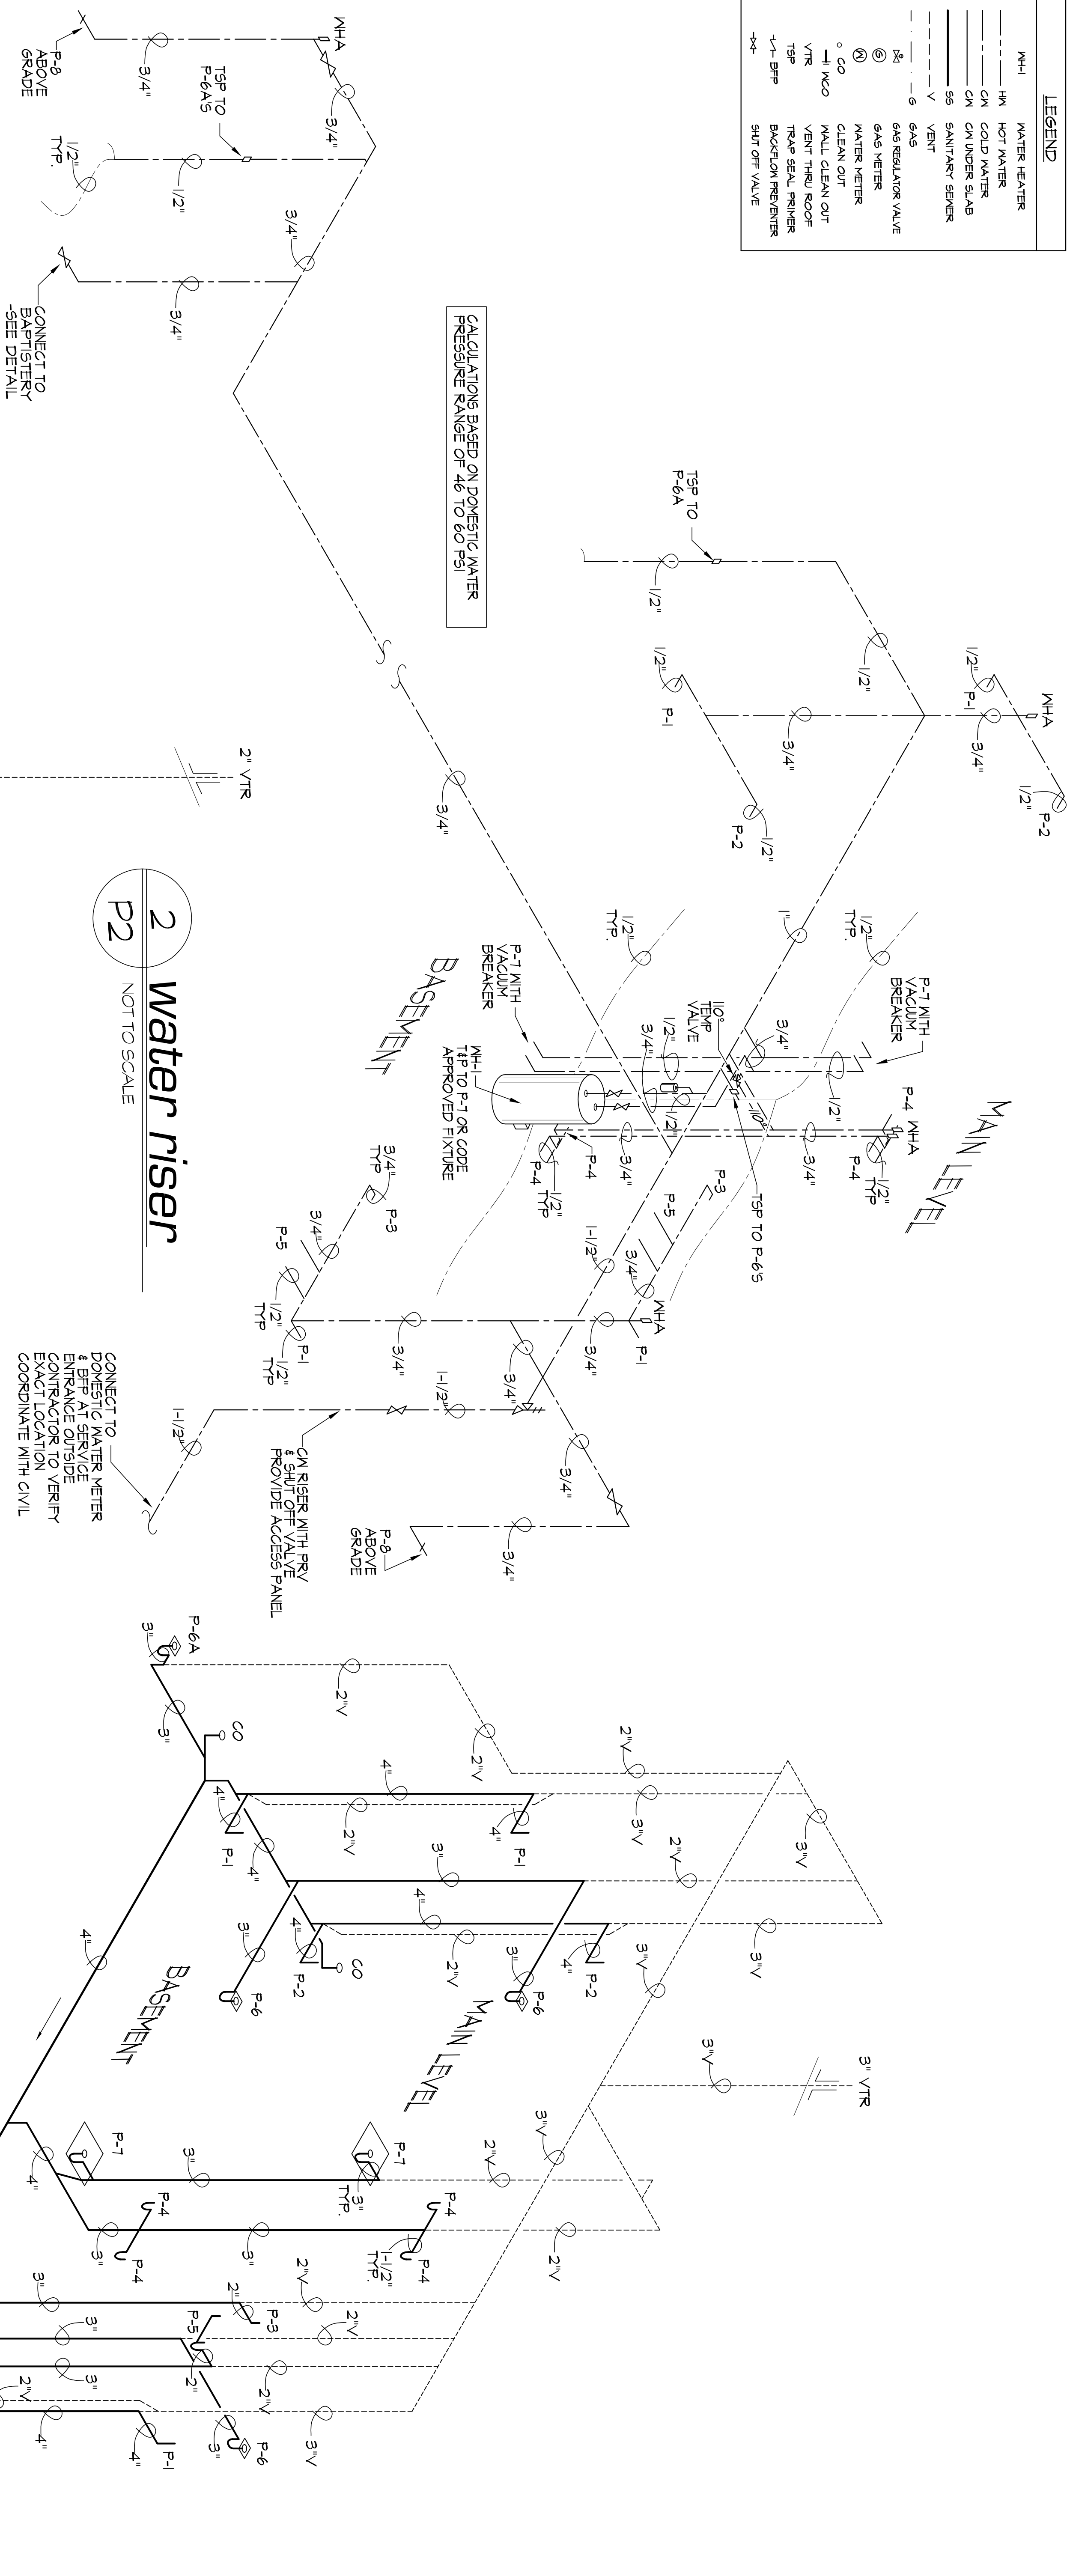

TOTAL FIXTURE UNITS - WATER DEMAND & DRAINAGE	CM SUPPLY		DRAINAGE	
	NUMBER (#) OF FIXTURES	SUPPLY UNIT	NUMBER (#) OF SUPPLY FIXTURE UNITS	NUMBER (#) OF DRAINAGE FIXTURE UNITS
LAVATORY	4	2	3	2
DRINKING FOUNTAIN	4	2	3	1
URINAL	2	4	3	2
WATER CLOSET (TANK)	6	5	30	6
FLUSH DRAINS	7	---	---	6
MOP SINK	2	4	3	6
BAPTISTRY	1	4	4	---
HOSE BIBBS	2	5	10	---
<b>TOTAL</b>		<b>TOTAL</b>	<b>76</b>	<b>TOTAL</b>
				<b>106</b>

**1 sanitary riser**  
NOT TO SCALE

**2 water riser**  
NOT TO SCALE

new facility for:  
**washington seventh day baptist church**  
CRITTENDEN @ 16TH, WASHINGTON, D.C.

REVISIONS
1
2
3
4
5

**rick jack/design**  
25 HEMLOCK RIDGE ROAD  
LEICESTER, NORTH CAROLINA 28748  
PH: 828-683-7348 FAX: 828-683-9902  
email: rick@rickjackdesign.com

project no. 2K70609  
drawn by: RPI  
date: AUG. 18, 2008  
scale: AS SHOWN  
sheet no. **P2**